



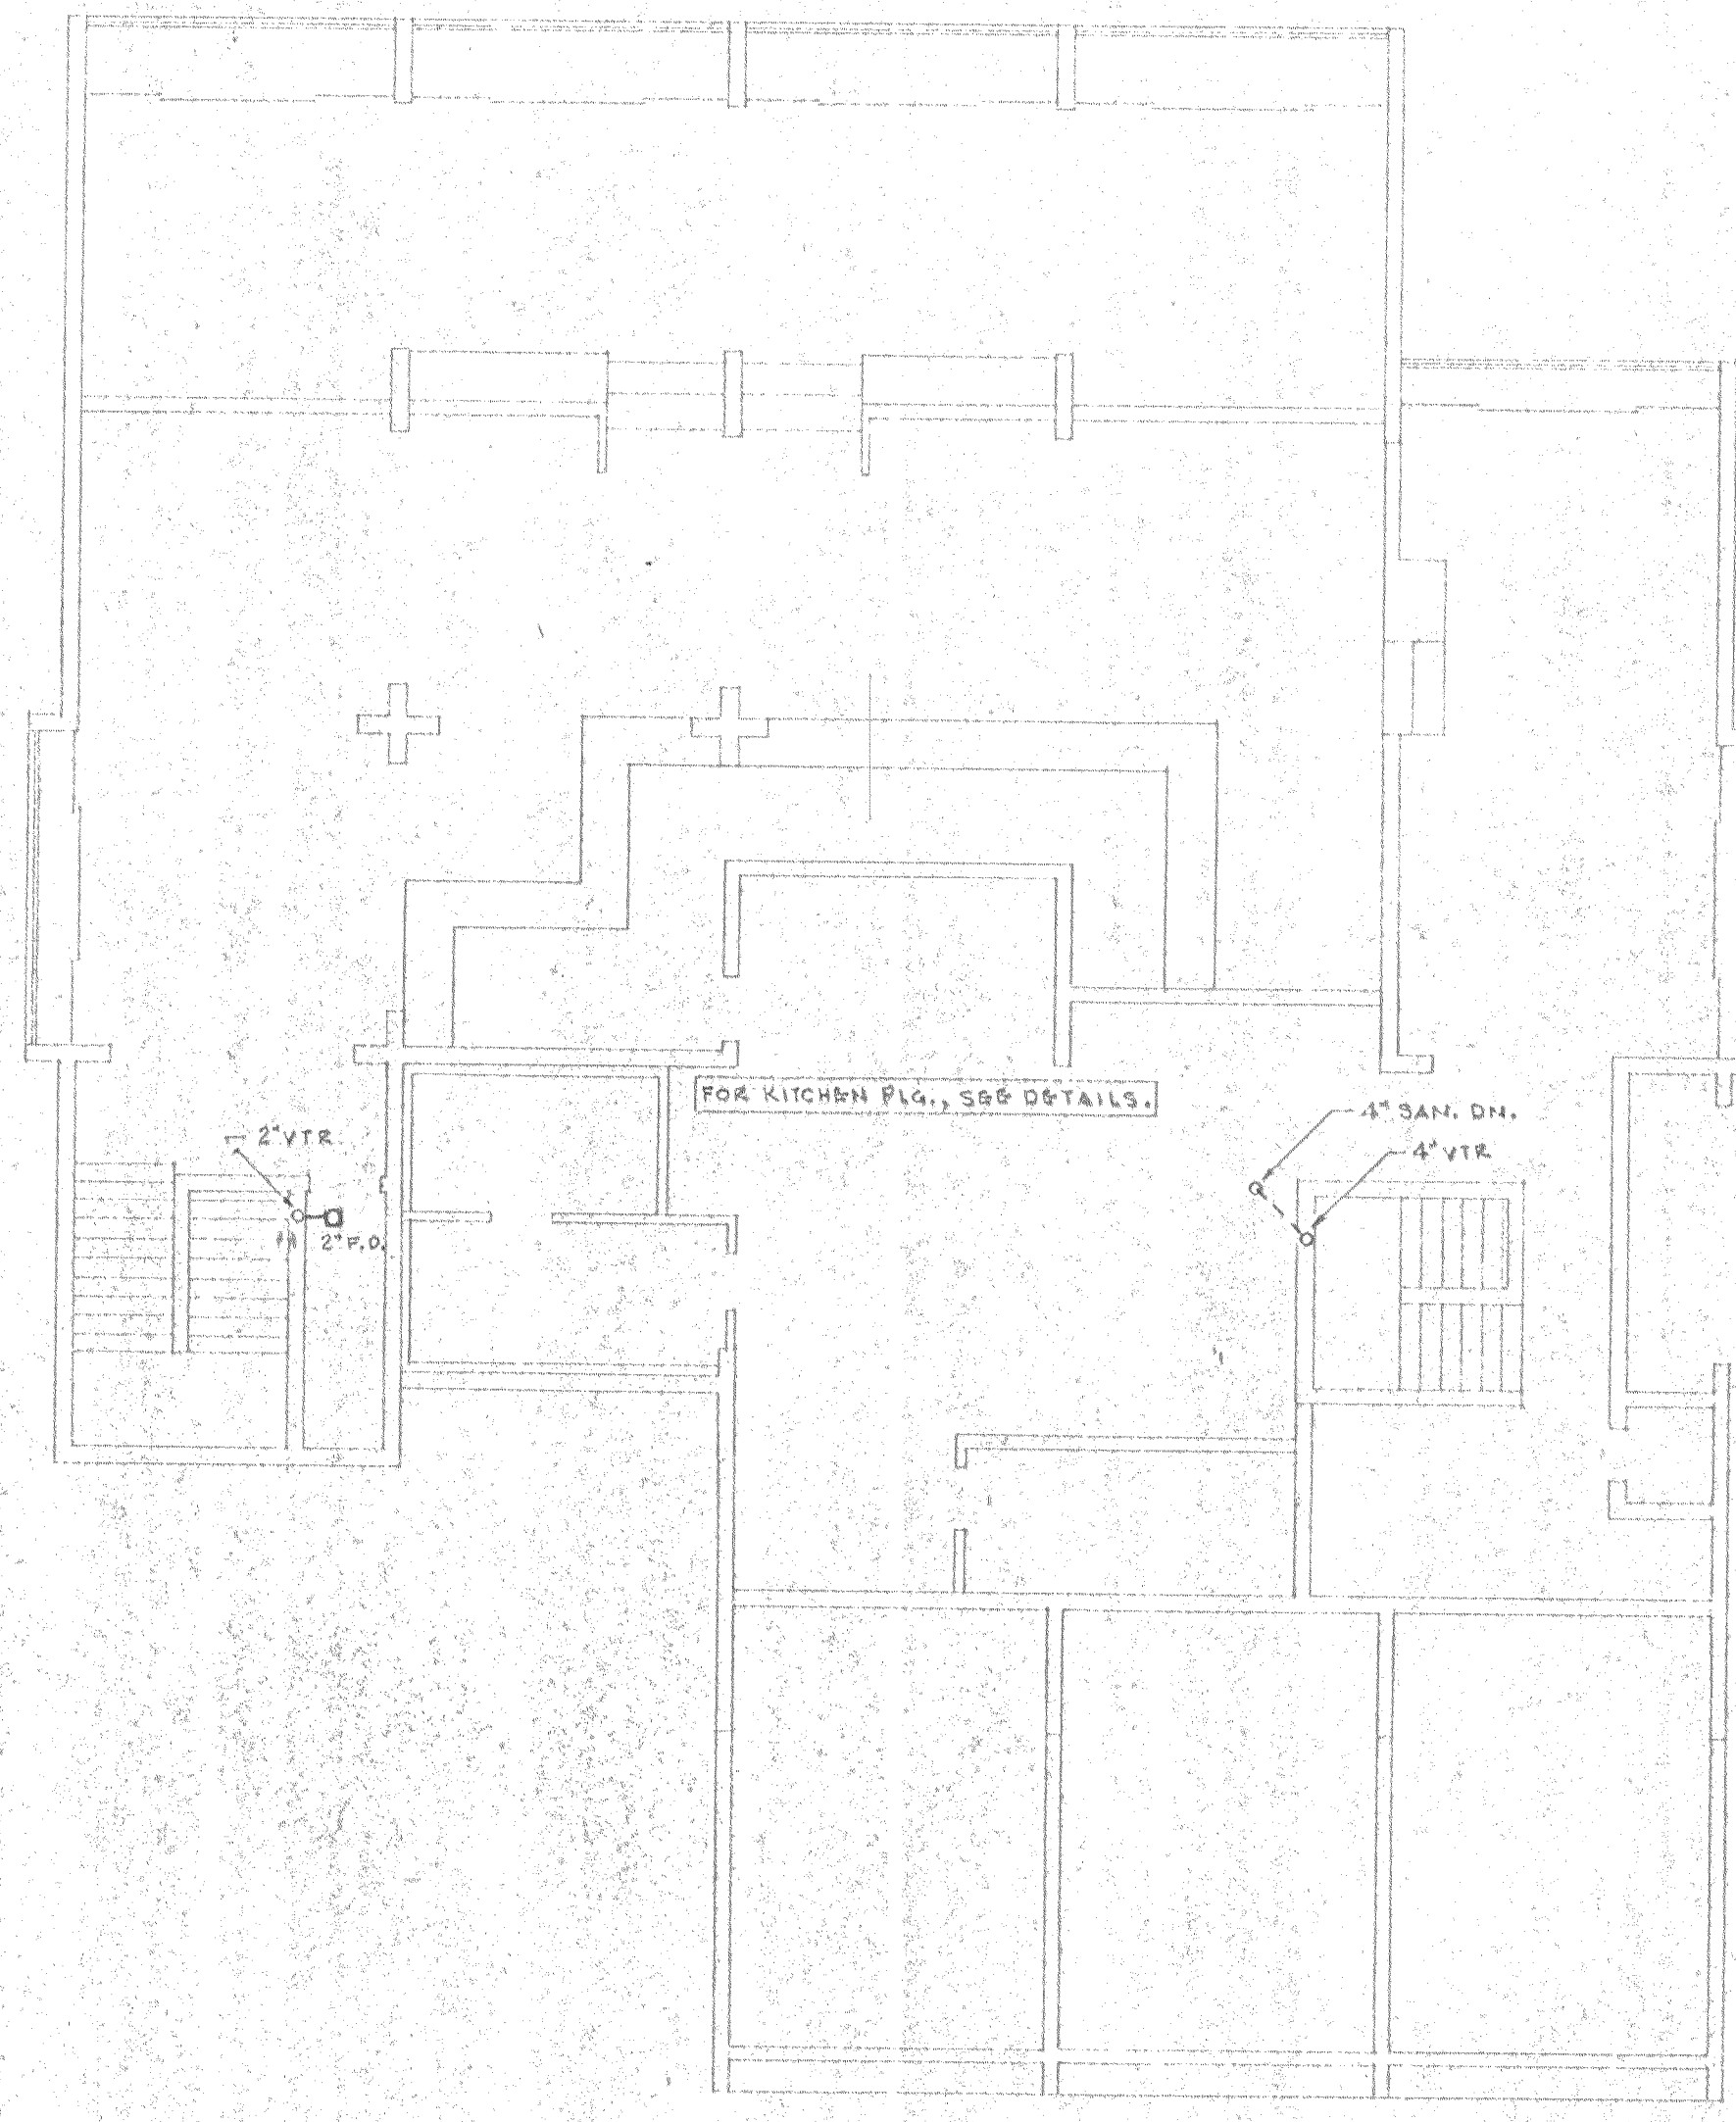

2ND FLOOR PLAN
1/8" = 1'-0"

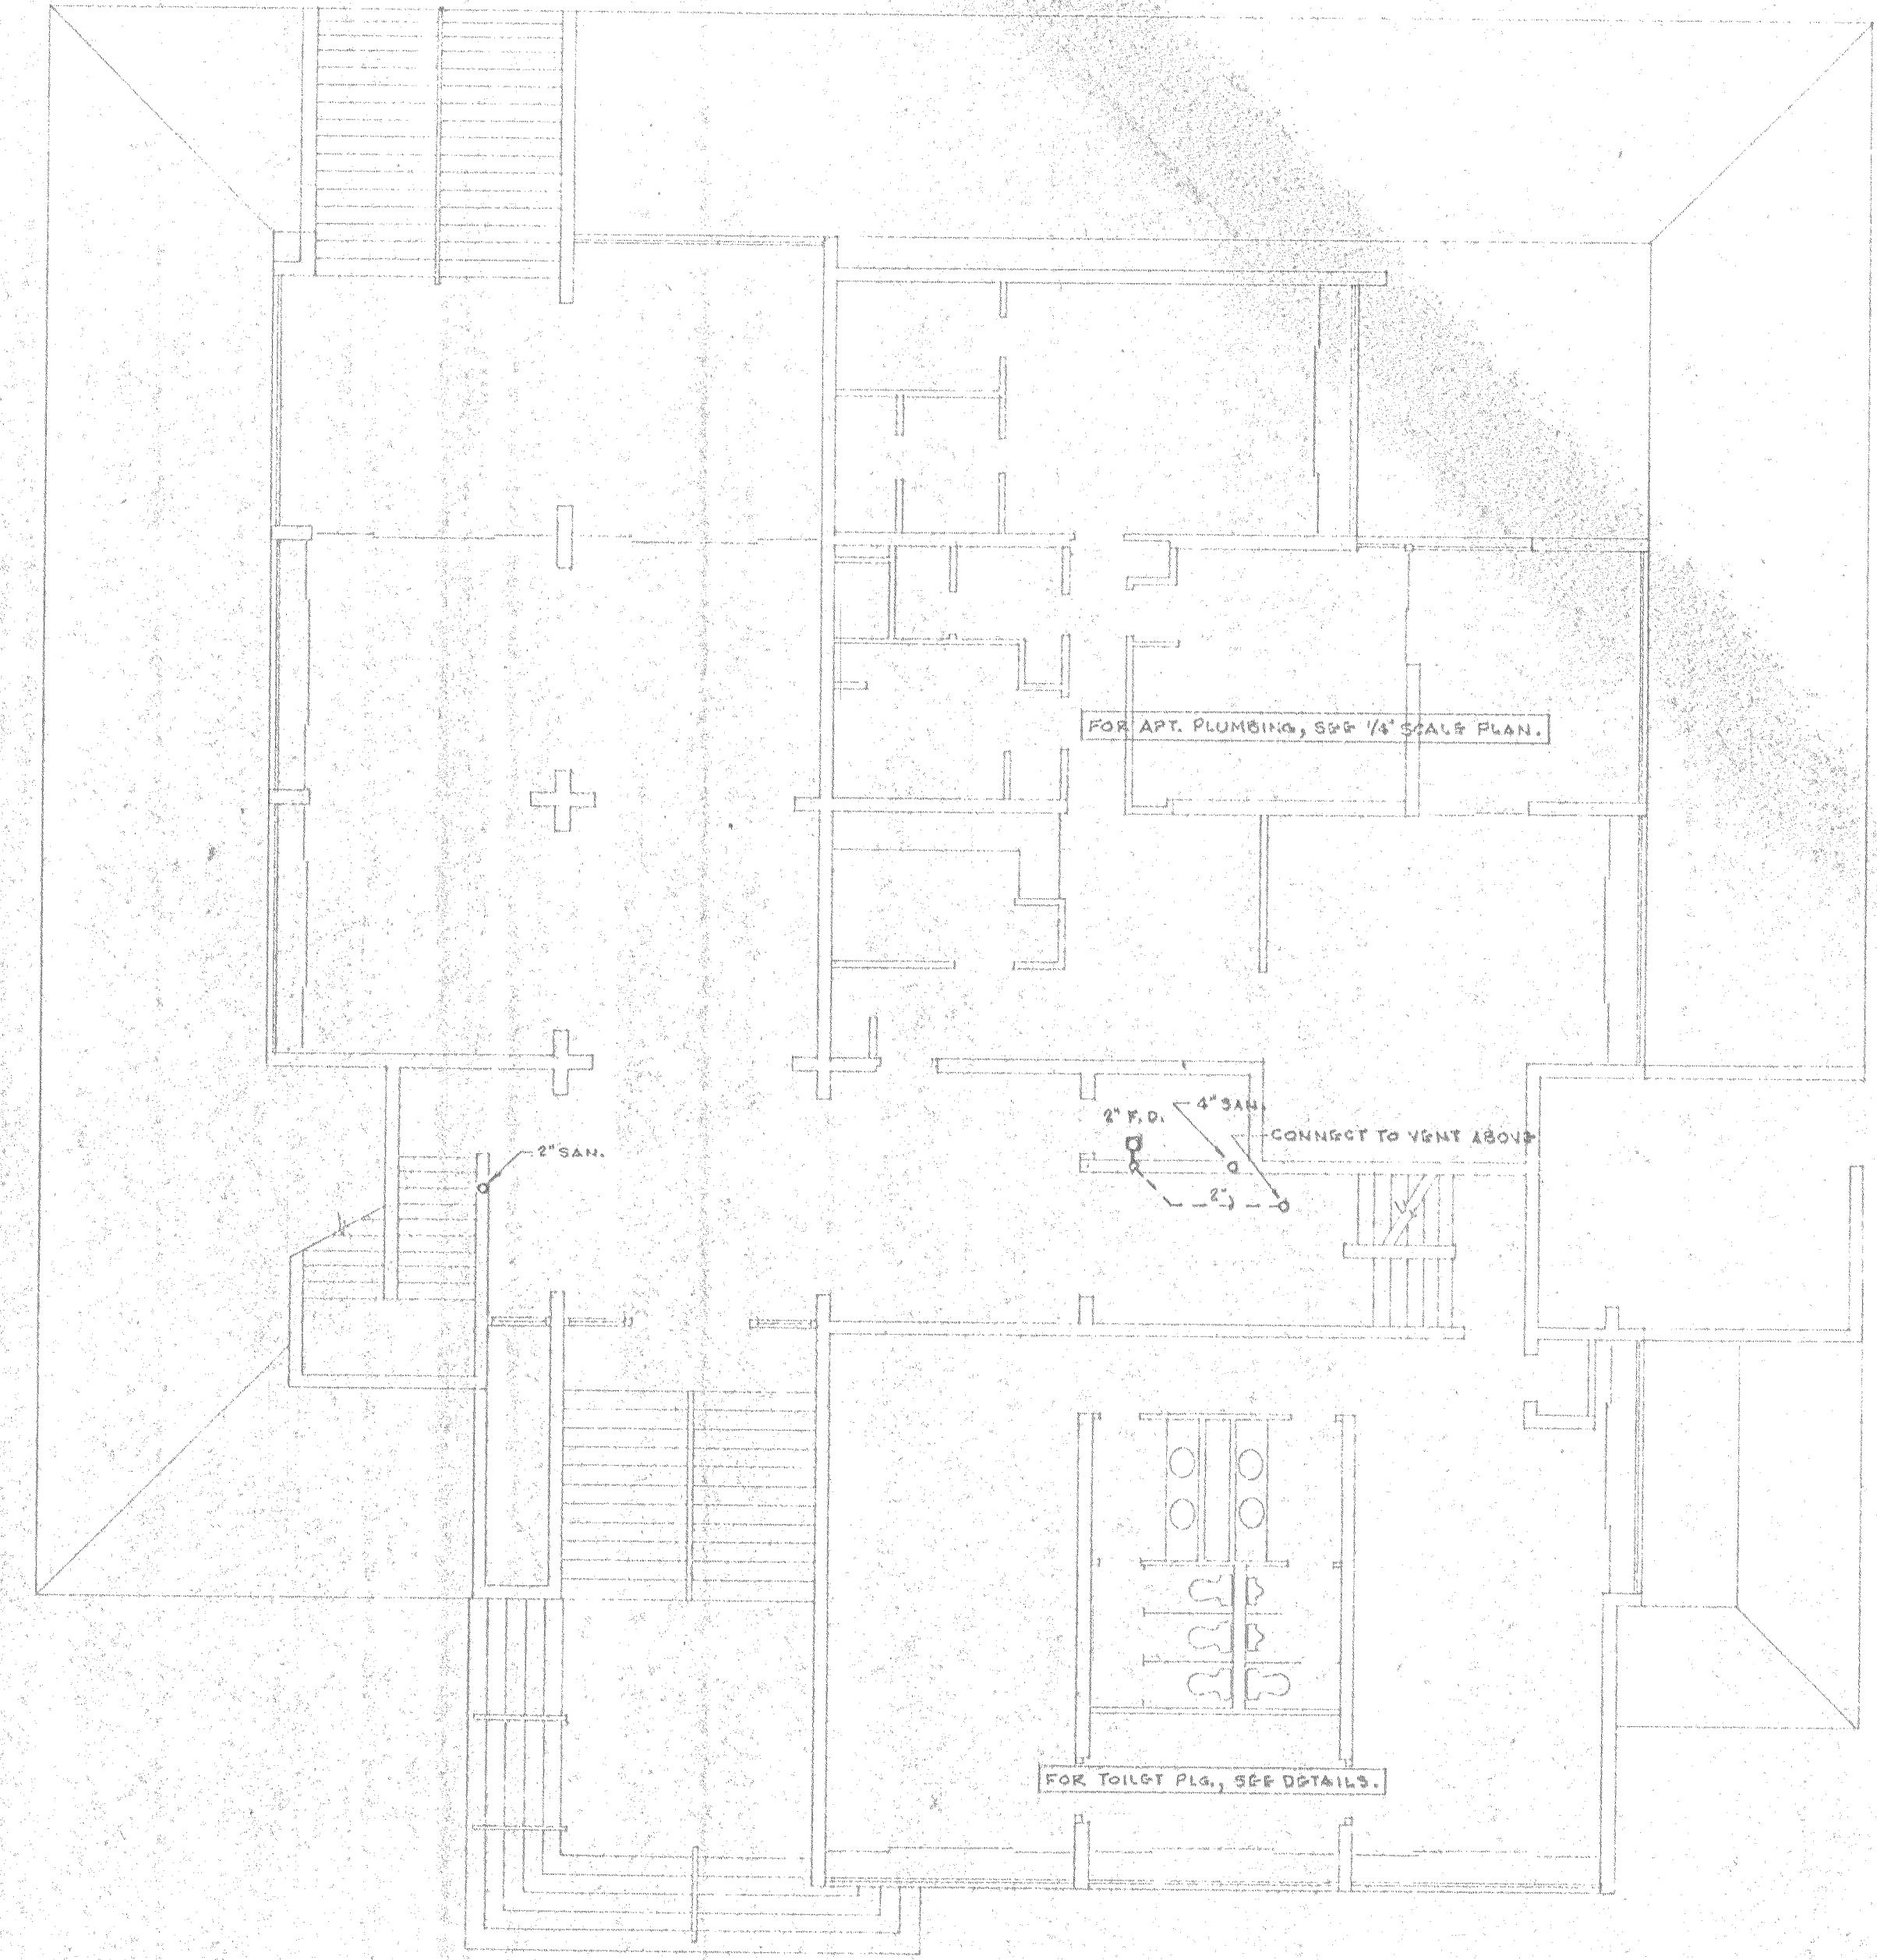

3RD FLOOR PLAN
1/8" = 1'-0"

SET NUMBER

SHEET NUMBER

P12

DATE 1/23/73

6-5-73

THE SAND KEY CLUB

SAND KEY - CLEARWATER, FLORIDA

FRIEDMAN & MCKENNA AIA ARCHITECTS

1211 N. WESTSHORE BLVD. SUITE 110 TAMPA, FLORIDA

PLUMBING PLAN