



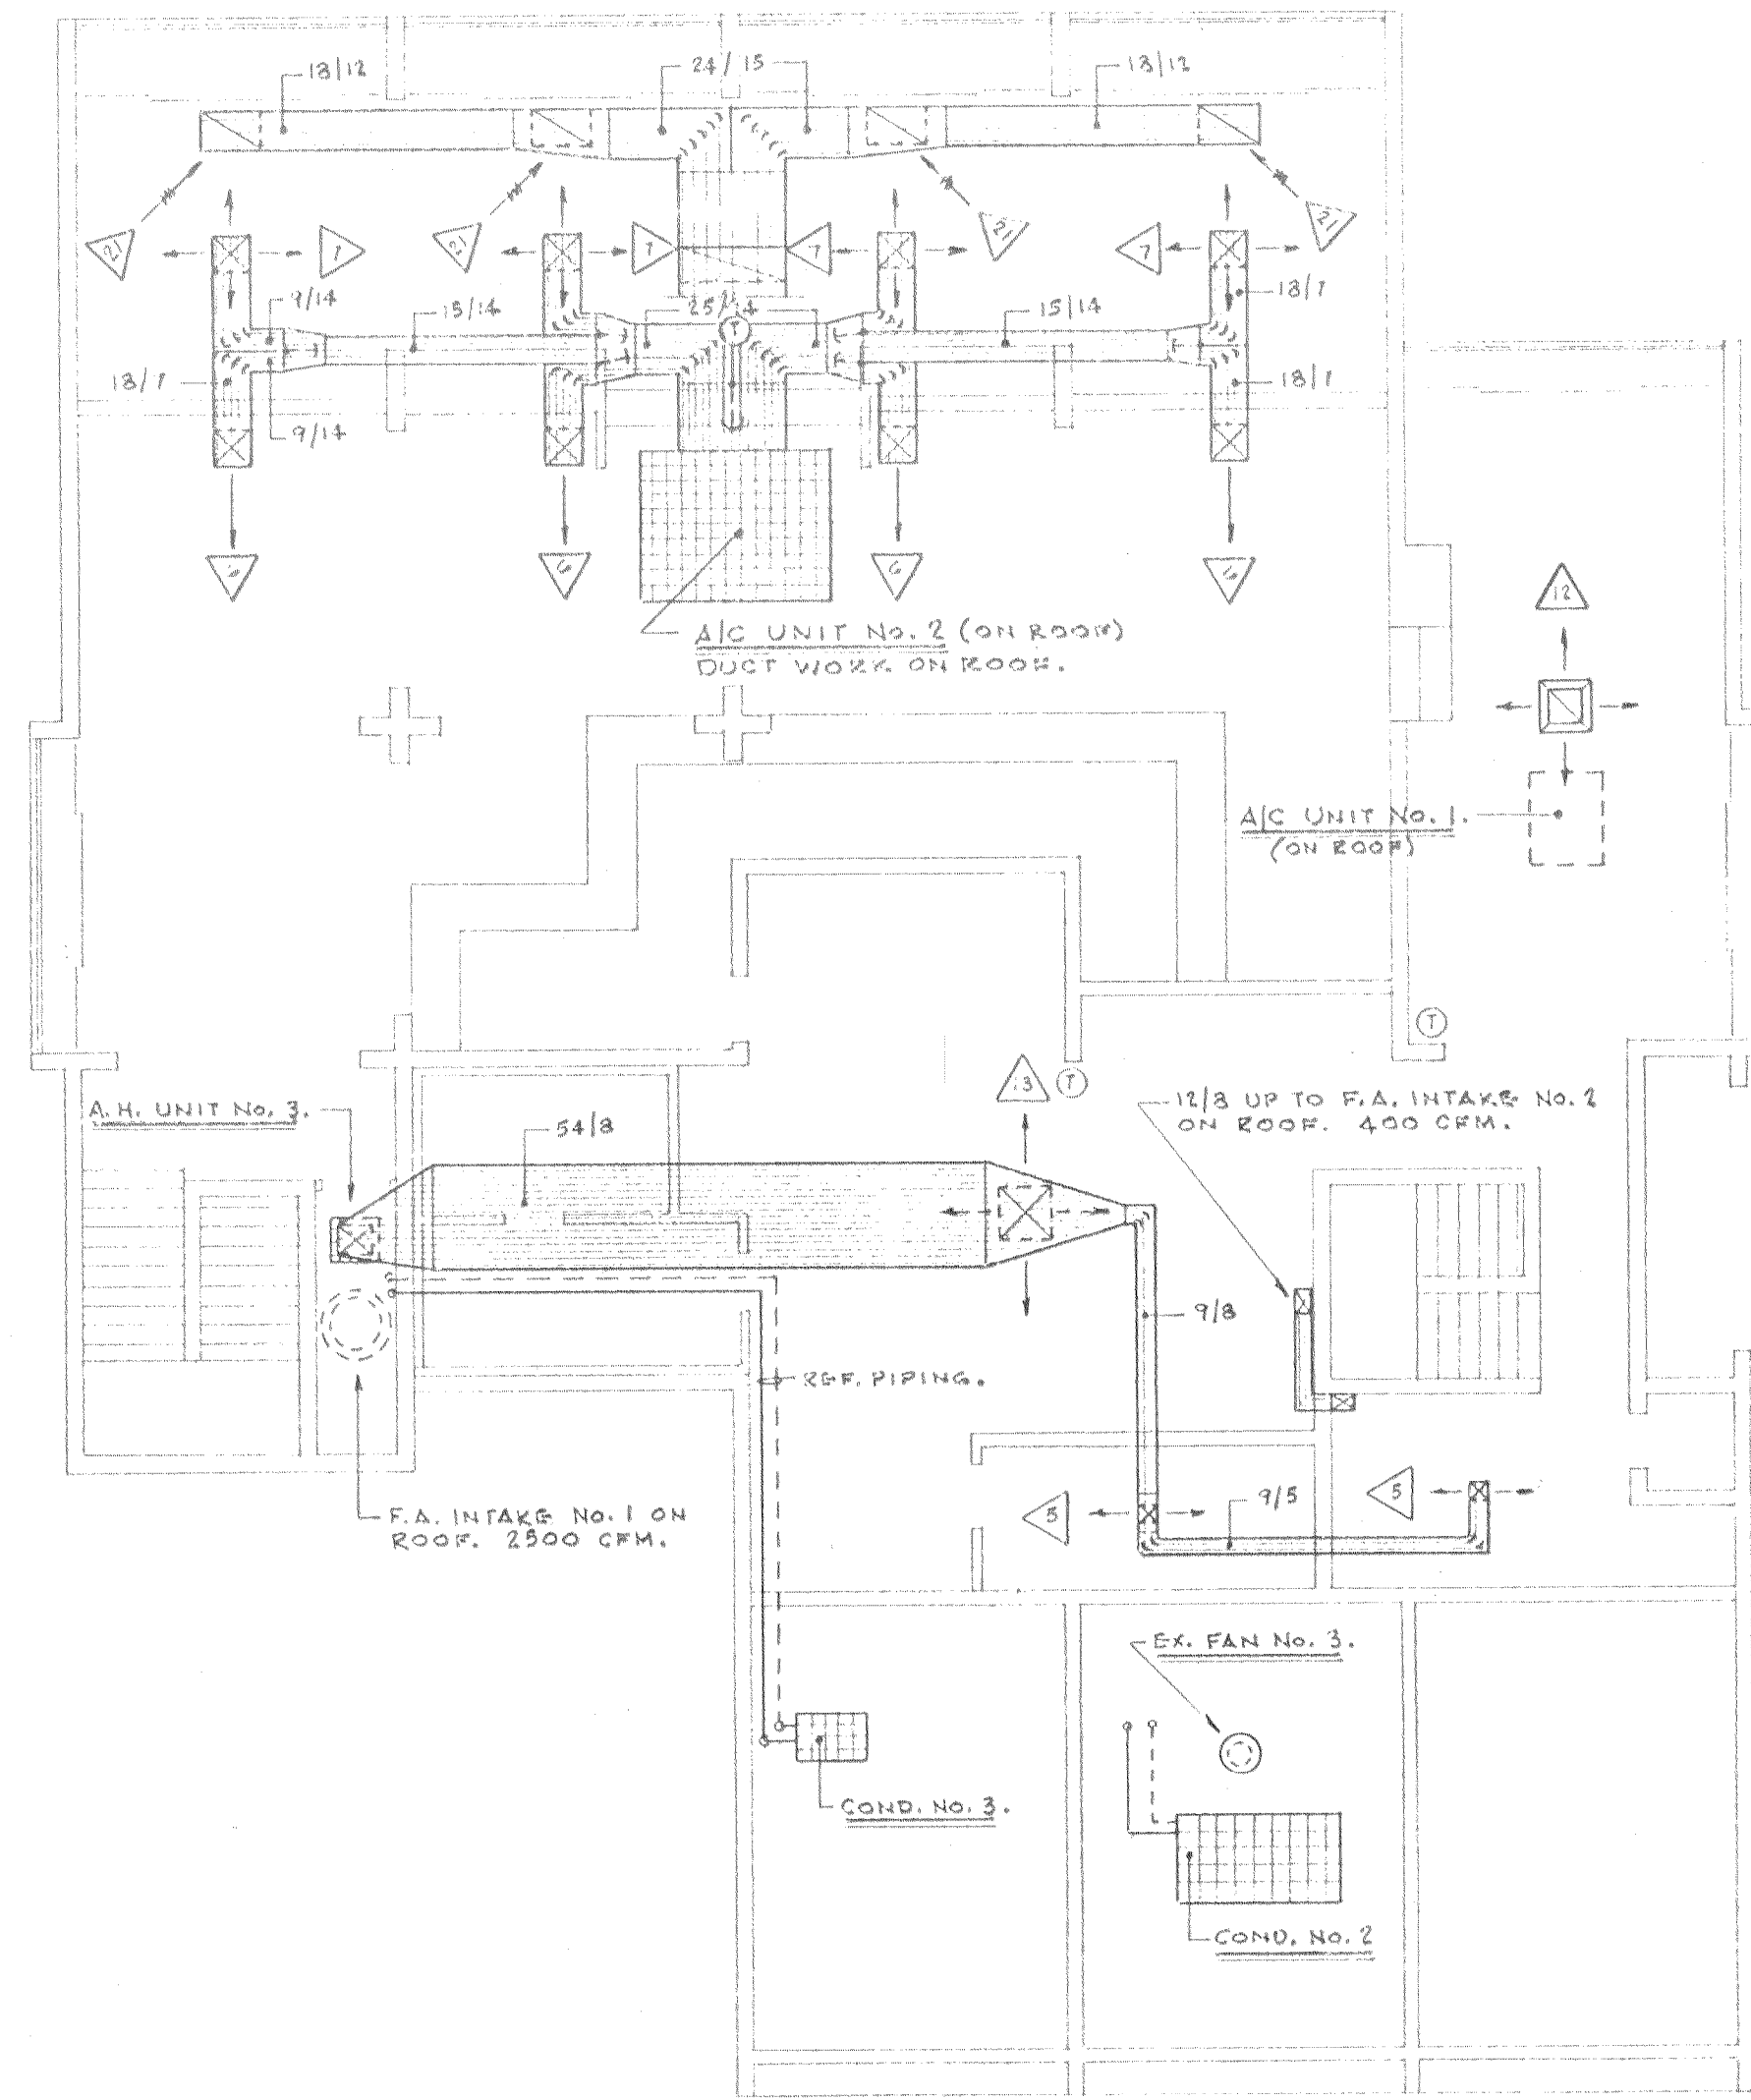

2nd FLOOR PLAN
1/8" = 1'-0"

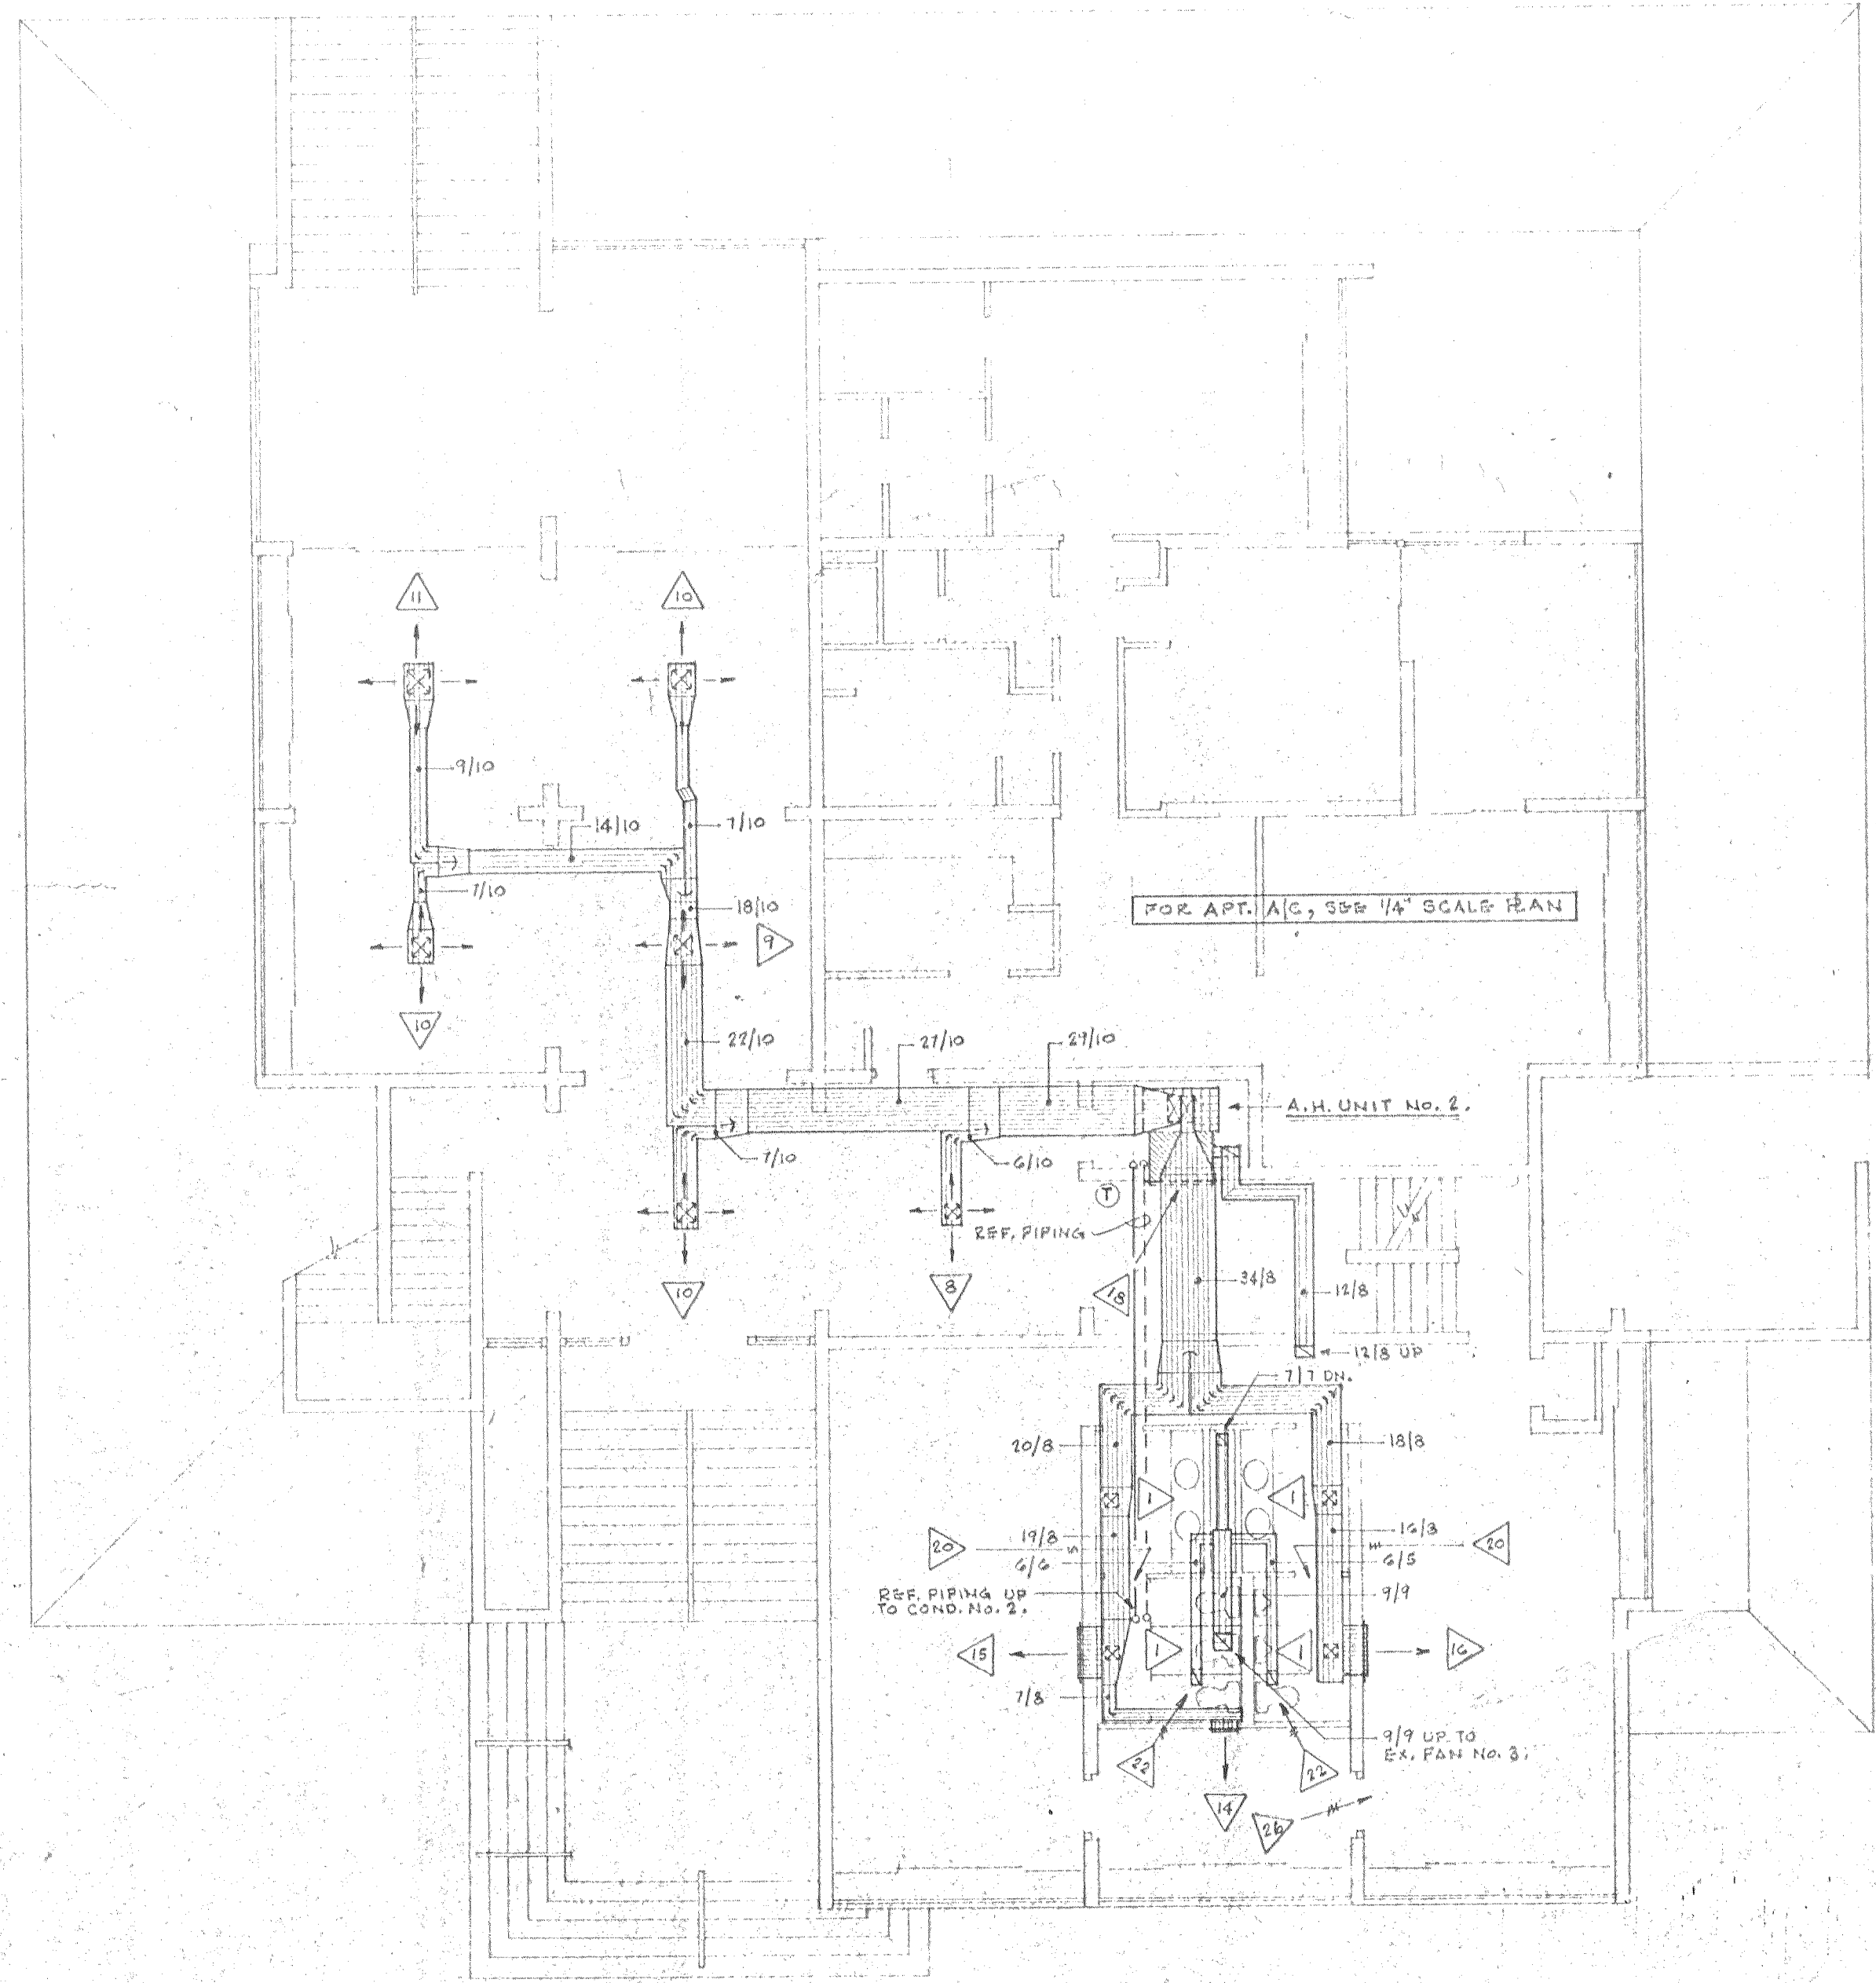

1st FLOOR PLAN
1/8" = 1'-0"

SET NUMBER

SHEET NUMBER

M10

DATE 8/23/73

8-15-73

THE SAND KEY CLUB

SAND KEY - CLEARWATER, FLORIDA

FRIEDMAN & MCKENNA AIA ARCHITECTS

121 N. WESTSHORE BLVD. SUITE 110 TAMPA, FLORIDA

CLUB BUILDING
MECHANICAL FLOOR PLAN
1st & 2nd FLOORS